
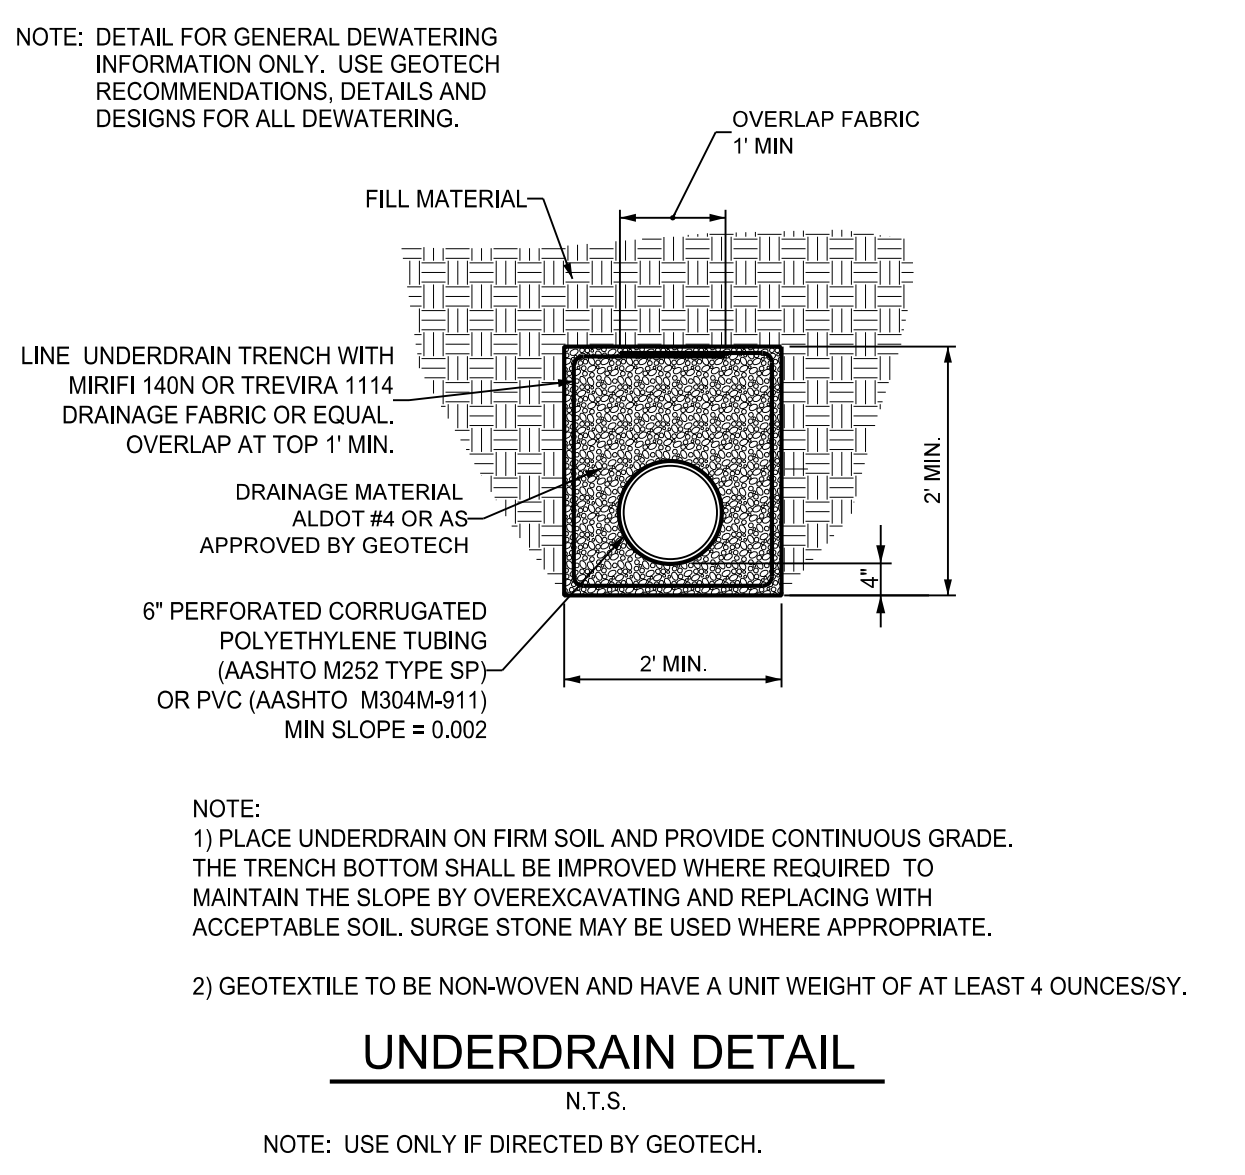
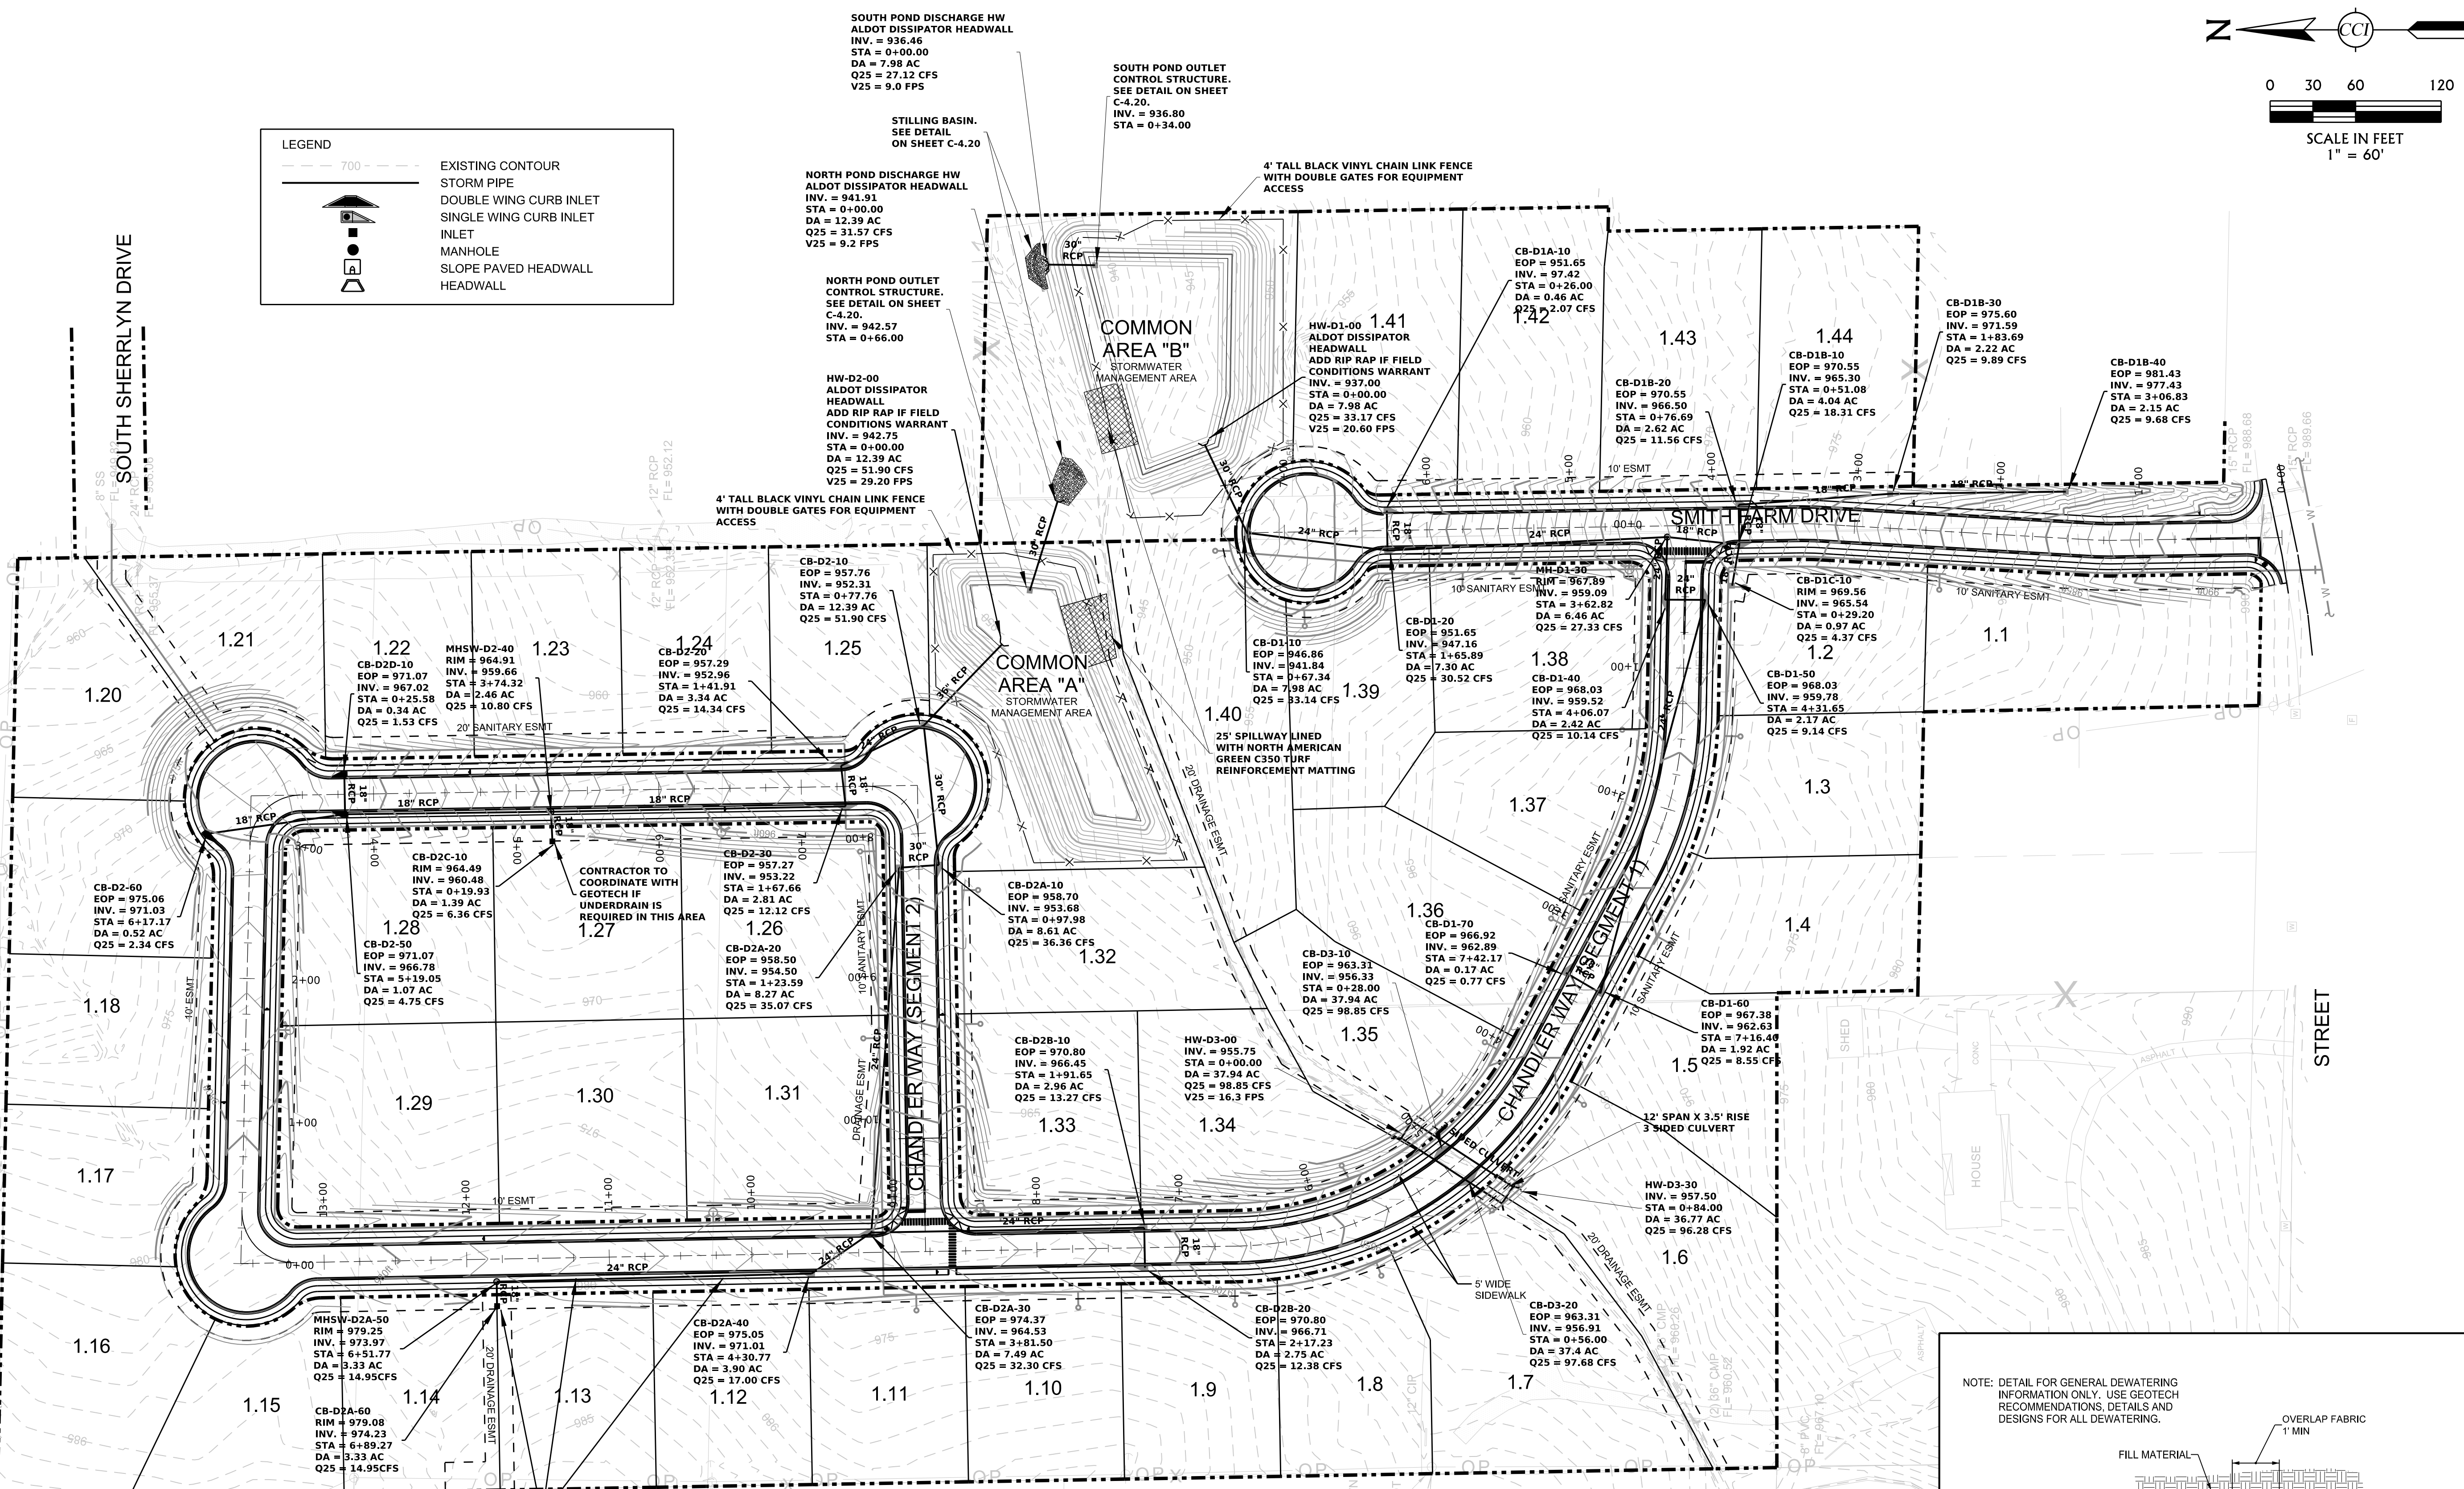
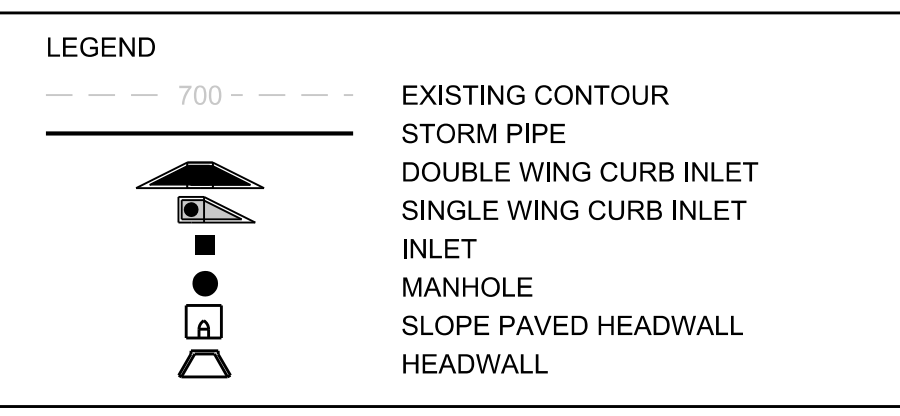


OVERALL DRAINAGE PLAN
SMITH FARM SUBDIVISION
HOOVER, ALABAMA
FOR
CK ENTERPRISES, LLC

DATE: 10/13/2020 PROJECT NO: KTC-H0001 DRAWN BY: JEL CHECKED BY: JEL T.E.D. SCALE: 1" = 60'

NO.	DESCRIPTION	BY	CHKD BY	REV. DATE
0	SUBMIT FOR CITY APPROVAL	JEL	TED	10/13/2020

DRAWING NO. **C-1.00**

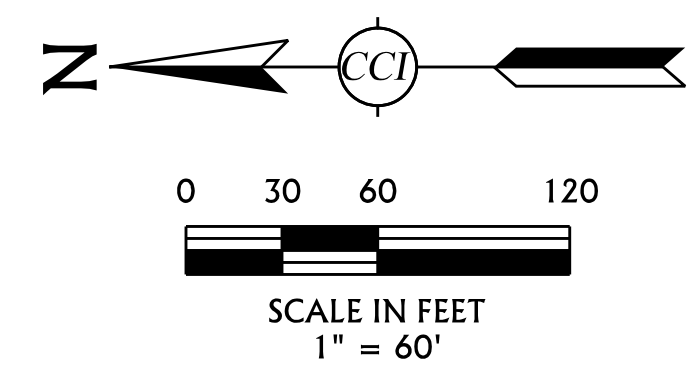

PRINTED: 10/20/20 1:58:45 PM P:\2020\10\13\2020\KTC-H0001\CADD\DRG\C-1.00 OVERALL DRAINAGE PLAN.dwg